

93

WHELEN LED MARKER LIGHTS
WHELEN WARNING AND SCENE LIGHTS
WHELEN 4500 SERIES LIGHTBAR

RL RL CL RL RL

VELVAC
#2020
MIRRORS

PREWIRE FOR GRILLE
LIGHTS

PREWIRE ONLY
SIREN SPEAKERS


REMOTE POWER DOOR SWITCH

68

86 1/4


103

16 3/4

DRAWN BY: <i>WRE</i>	REVISIONS	DRAWING TITLE: FRONT EXTERIOR VIEW - 68" H.R.
DATE: 10/12/10	MARQUE ~ ~ ~  AMBULANCES	TYPE/MODEL/CHASSIS: TYPE III-148 COMMANDO-FORD E450
<small>Drawing is representative only - Discrepancies between the equipment and may vary from the completed vehicle DO NOT scale this drawing!</small>		DEALER / CUSTOMER: LIFE ALERT - MAHONING VALLEY EMS
		UNIT NUMBER: 4597 - 98 PRINT NUMBER: 3-148CMDO-001

93


WHELEN LED MARKER LIGHTS
WHELEN WARNING AND SCENE LIGHTS

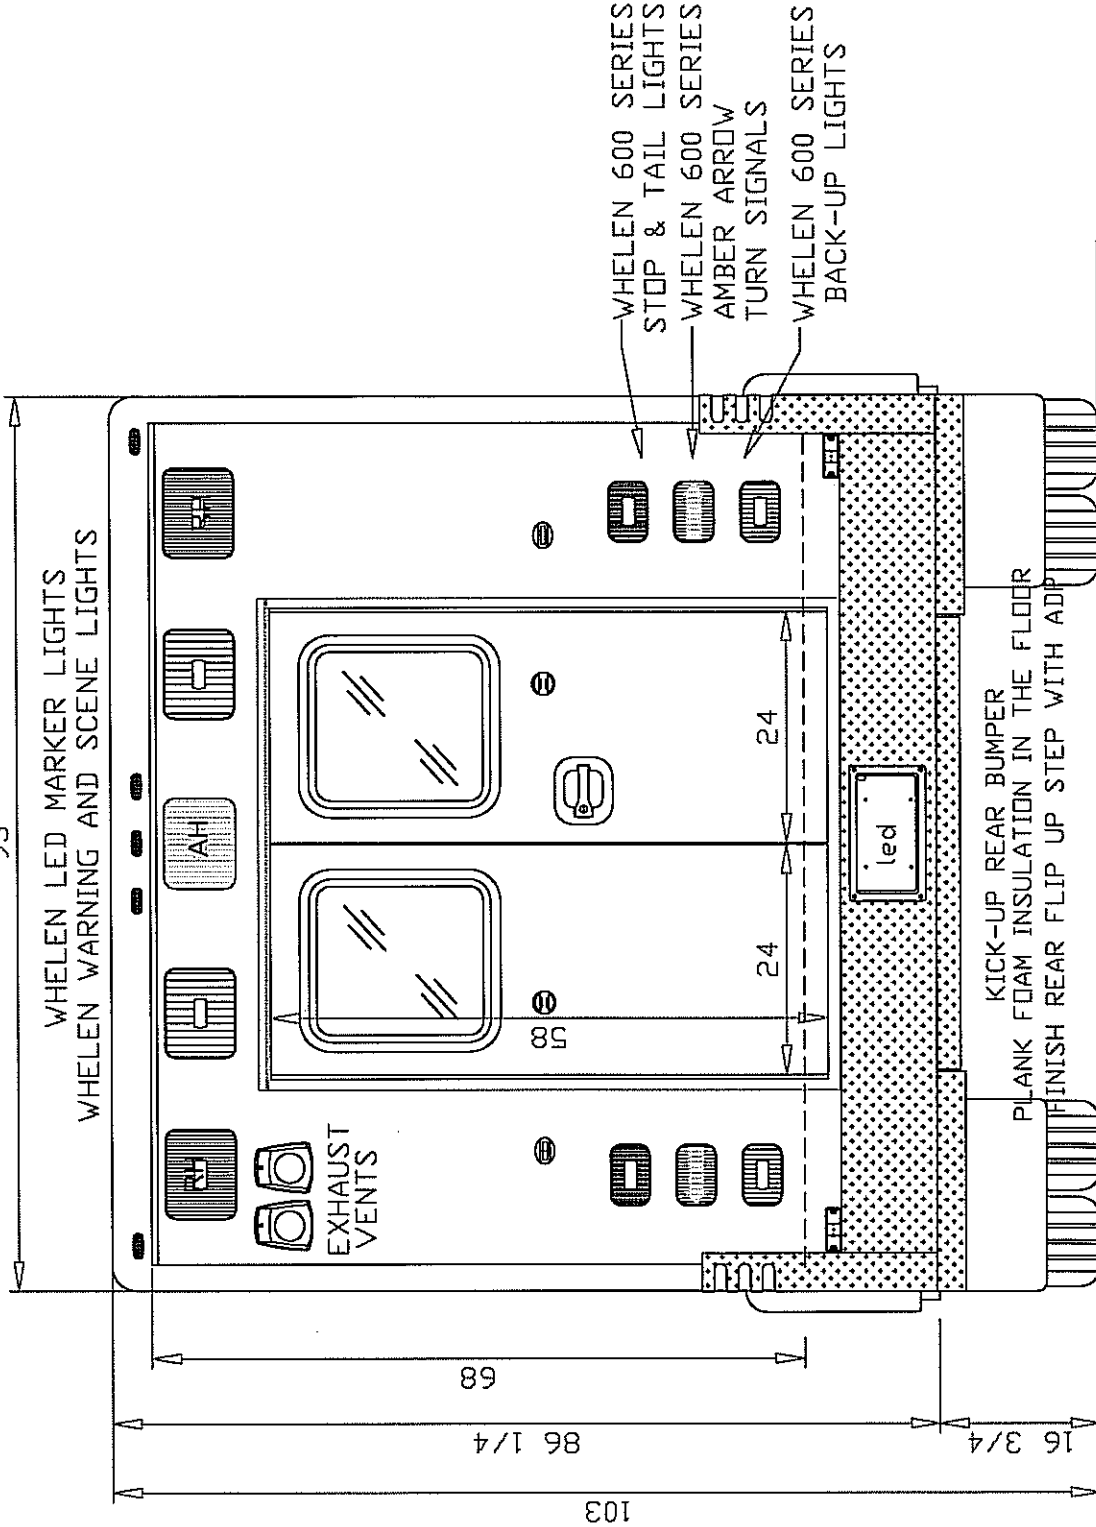


POWER DOOR LOCKS ON ENTRY DOORS.

DRAWN BY: <i>MCR</i>	REVISIONS	DRAWING TITLE: REAR EXTERIOR VIEW - 68' H.R.
DATE: 10/12/10		TYPE/MODEL/CHASSIS TYPE III-148 COMMANDO-FORD E450
		DEALER/CUSTOMER: LIFE ALERT - MAHONING VALLEY EMS
		UNIT NUMBER: 4597 - 98 PRINT NUMBERT3-148CMD0-002
		MARQUE ~ ~ ~

Drawing is representative only - Dimensions shown are approximate and may vary from the completed vehicle DO NOT scale this drawing!

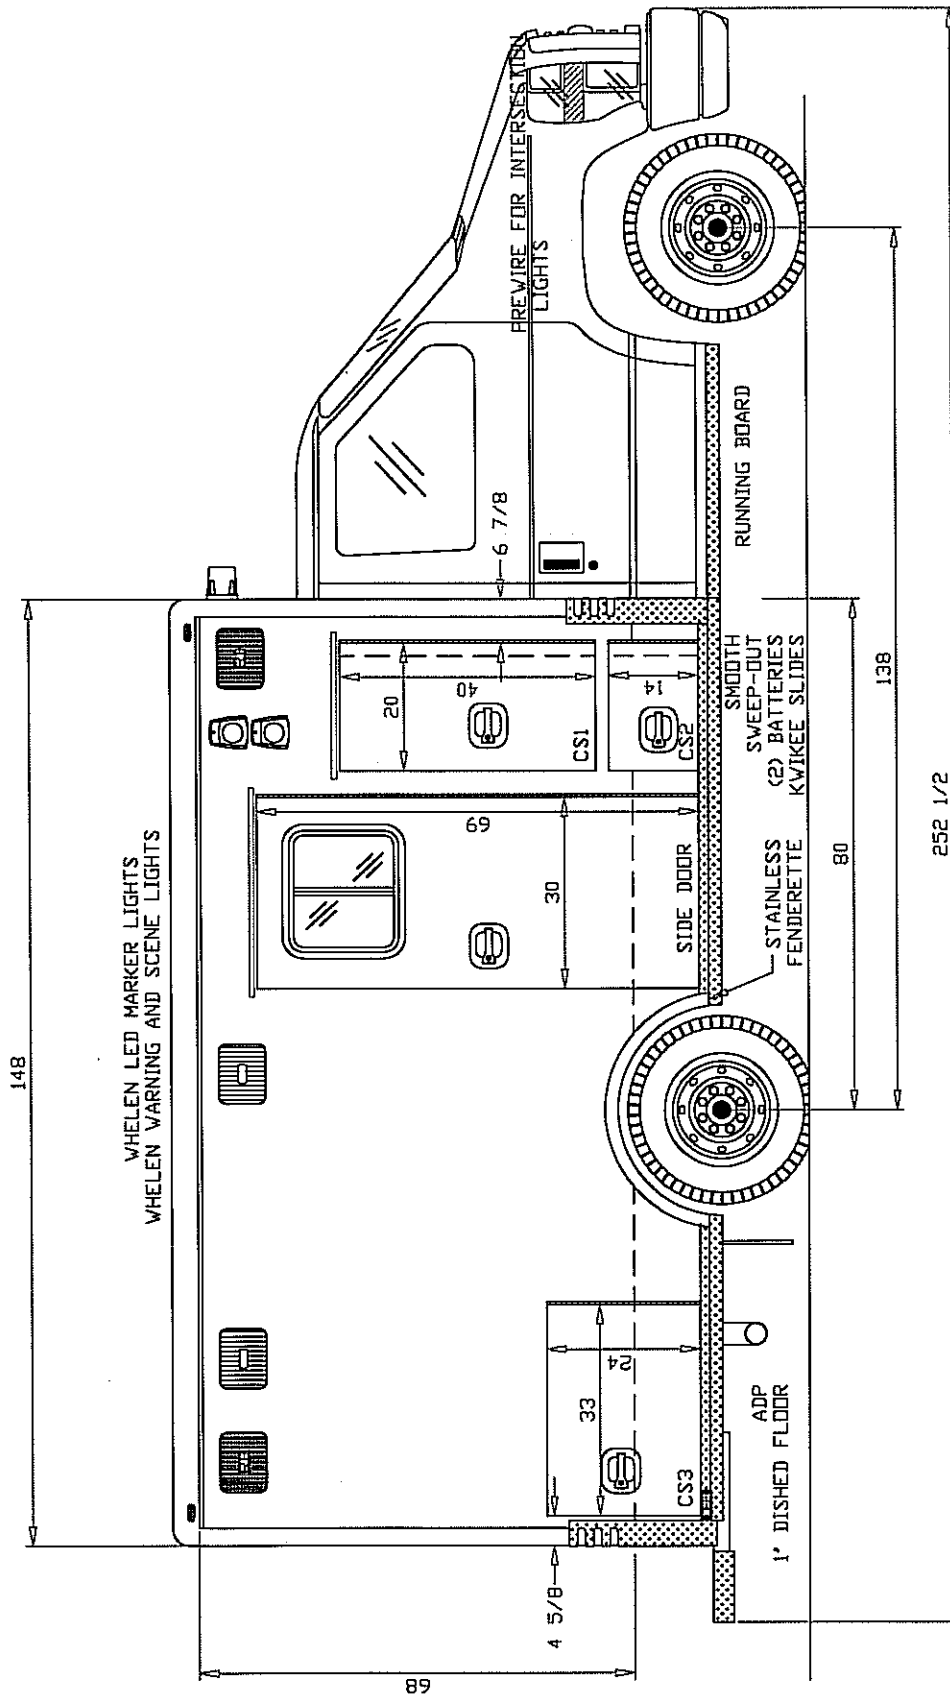


POWER DOOR LOCKS ON ENTRY DOORS.
ADP SILL TRIM

DRAWN BY: <i>MARY</i>	REVISIONS	DRAWING TITLE: CURBSIDE EXTERIOR VIEW - 68" H.R.
DATE: 10/12/10		TYPE/MODEL/CHASSIS TYPE III-148 COMMANDO-FORD E450
		DEALER/CUSTOMER: LIFE ALERT - MAHONING VALLEY EMS
		UNIT NUMBER: 4597 - 98 PRINT NUMBER: 3-148CMD0-003
		MARQUE ~ ~ ~  AMBULANCES

Drawing is representative only - Dimensions shown are approximate and may vary from the completed vehicle DO NOT scale this drawing!

148

WHELEN LED MARKER LIGHTS
WHELEN WARNING AND SCENE LIGHTS

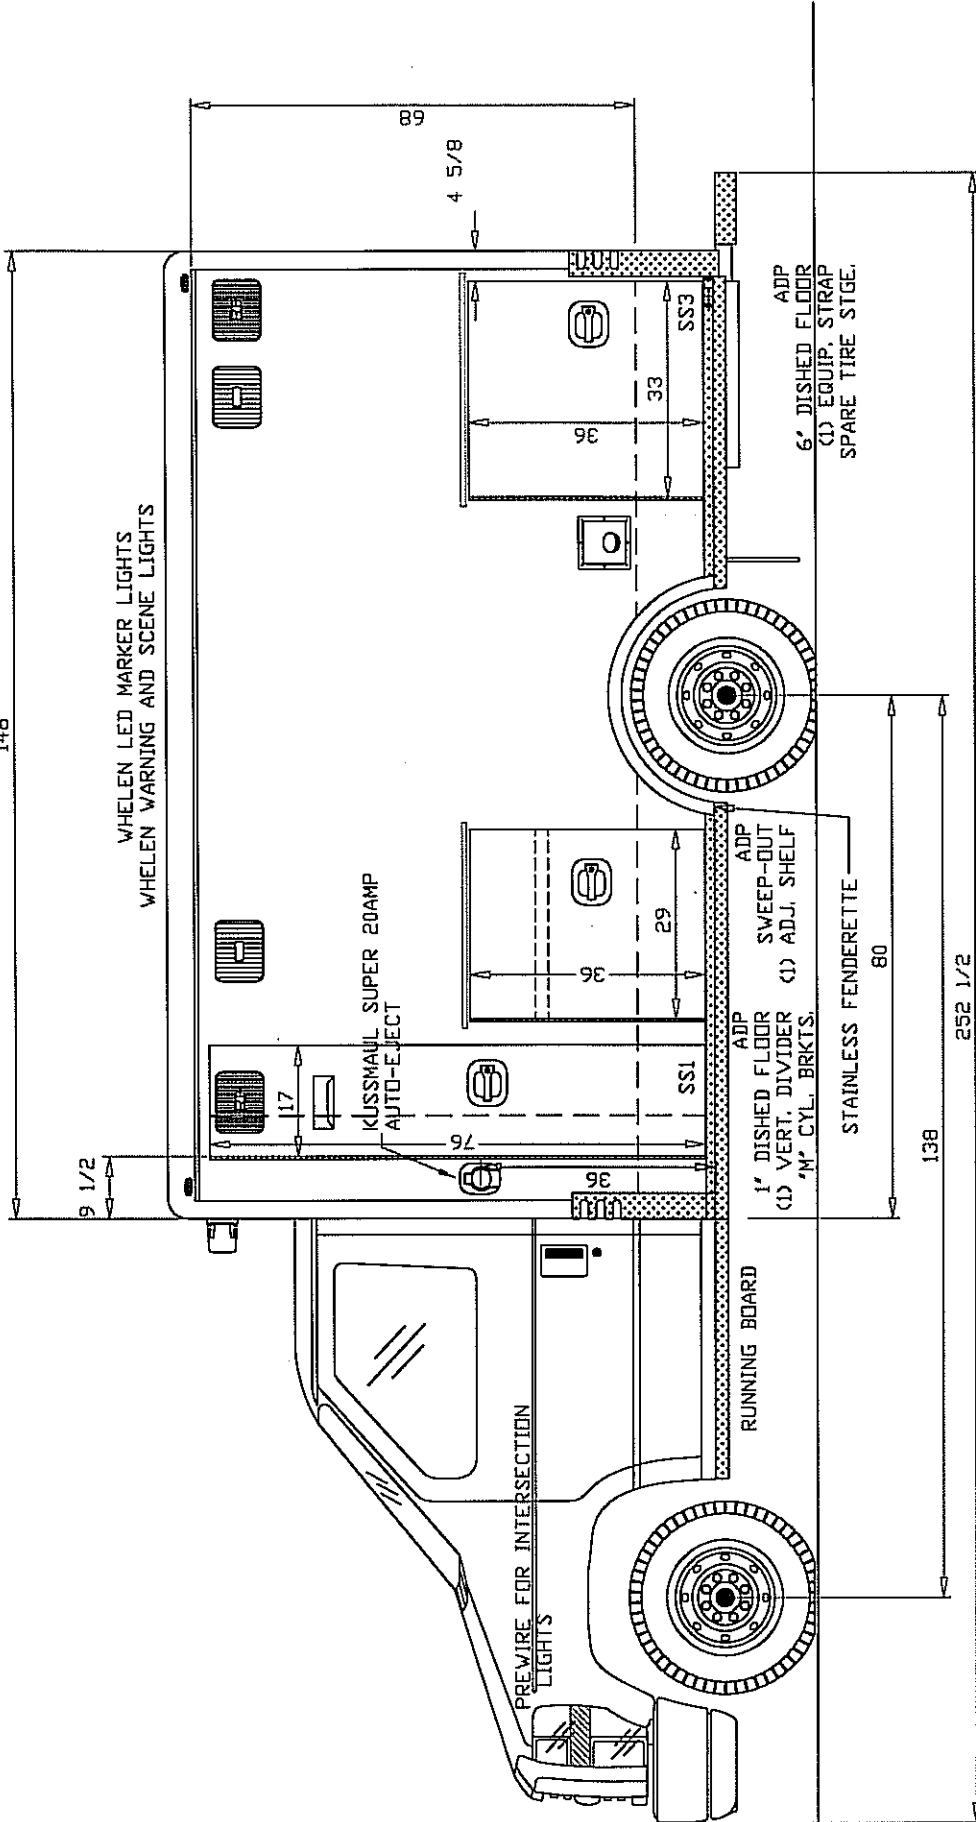


ADP SILL TRIM

DRAWING TITLE: STREETSIDE EXTERIOR VIEW - 68" H.R.
 TYPE/MODEL/CHASSIS: TYPE III-148 COMMANDO-FORD E450
 DEALER / CUSTOMER: LIFE ALERT - MAHONING VALLEY EMS
 UNIT NUMBER: 4597 - 98 | PRINT NUMBER: T3-148CMDO-004


MARQUE ~ ~ ~ AMBULANCES

DRAWN BY:	REVISIONS
MERZ	
DATE: 10/12/10	
<small>Drawing is representative only - Dimensions shown are taken from the completed vehicle and may not scale this drawing!</small>	

DUCTED
HEAT/AC

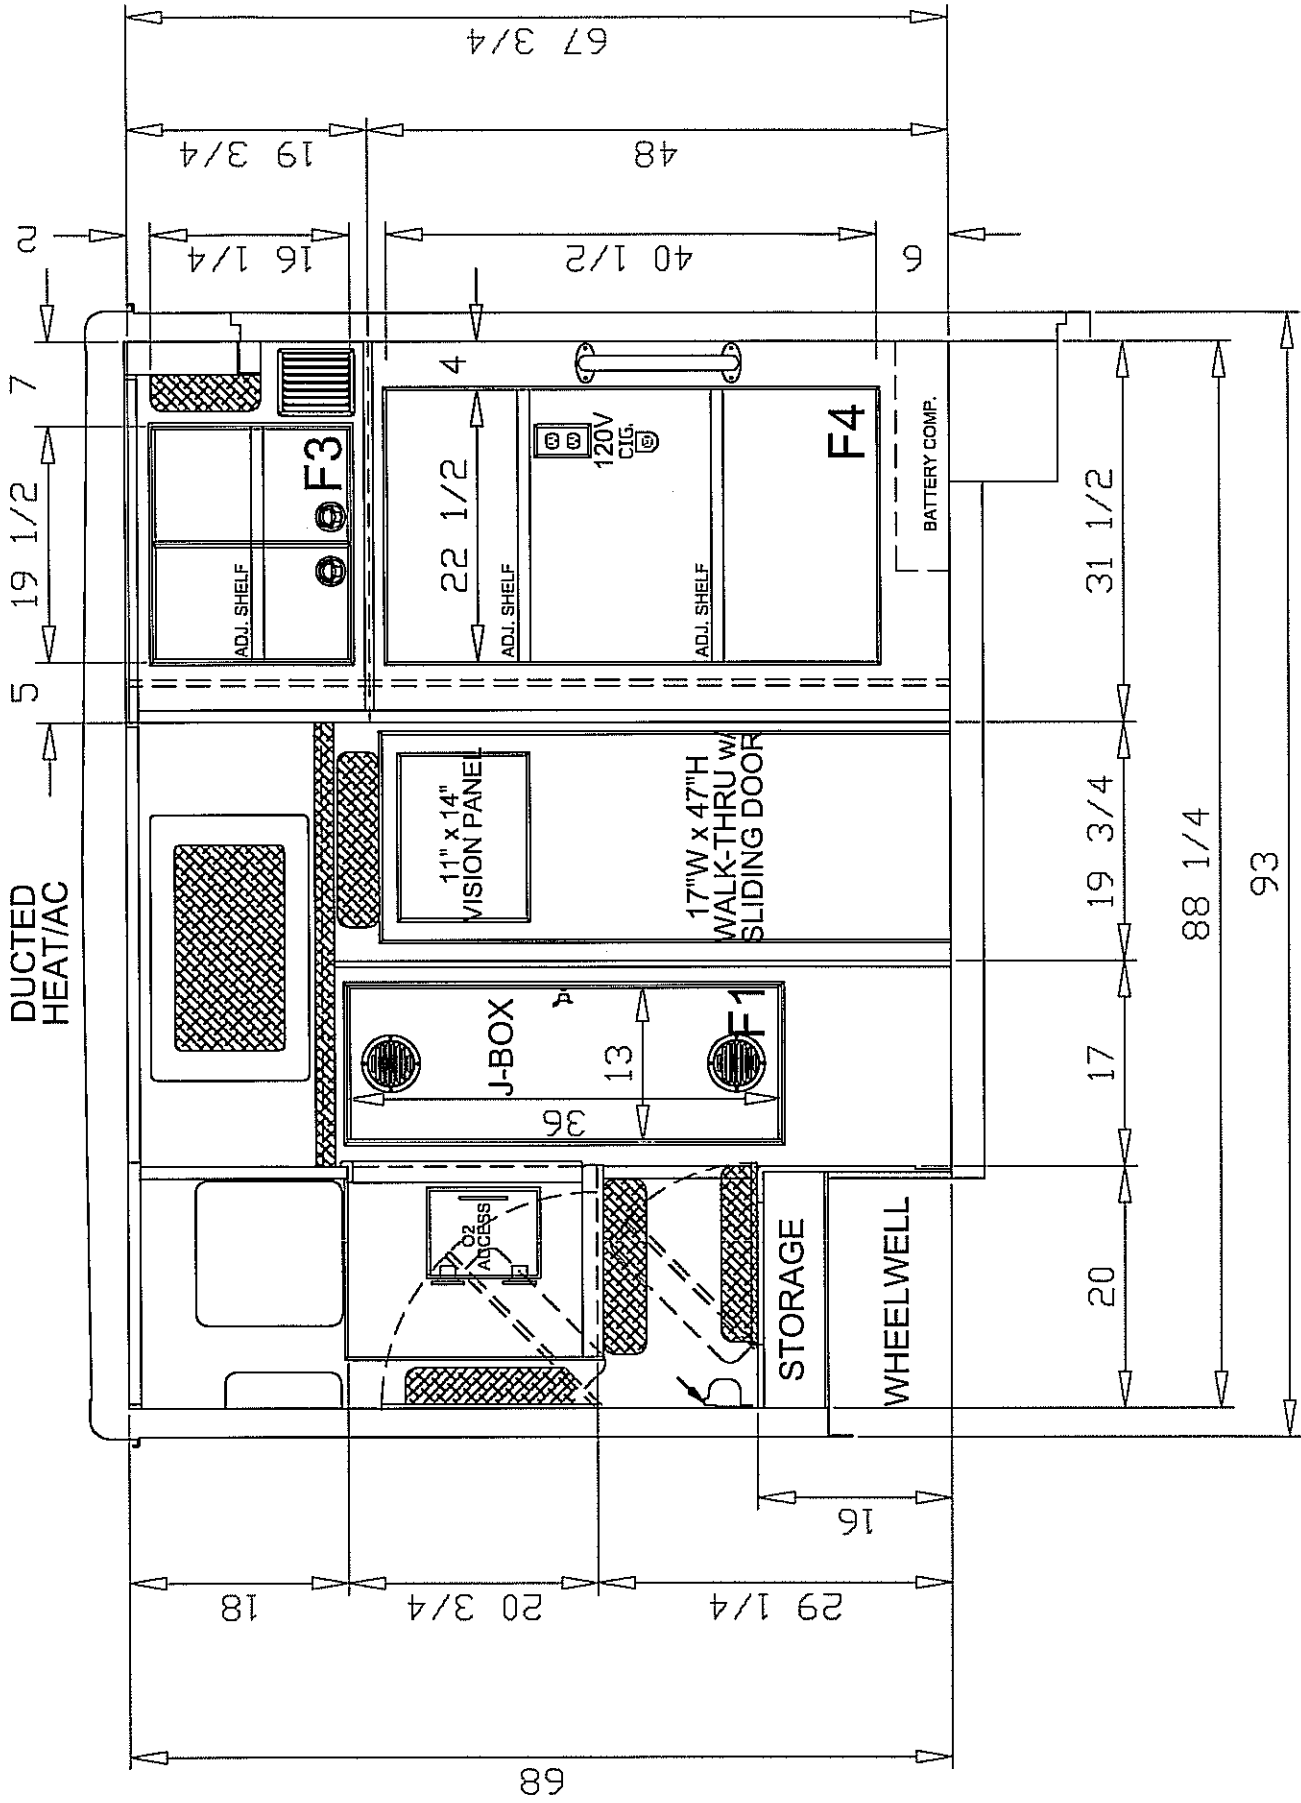


DRAWN BY: <i>MFR</i>	REVISIONS	DRAWING TITLE: FRONT INTERIOR VIEW - 68' H.R.
DATE: 10/12/10		MODEL/TYPE/CHASSIS/TYPE III - 148 COMMANDO
<small>Drawing is representative only - Dimensions shown are for information only and are not to scale (this drawing)</small>		DEALER / CUSTOMER: LIFE ALERT - MAHONING VALLEY EMS
		UNIT NUMBER: 4597 - 98 PRINT NUMBER: T3-148CMD0-005
		MARQUE ~ ~ ~ AMBULANCES

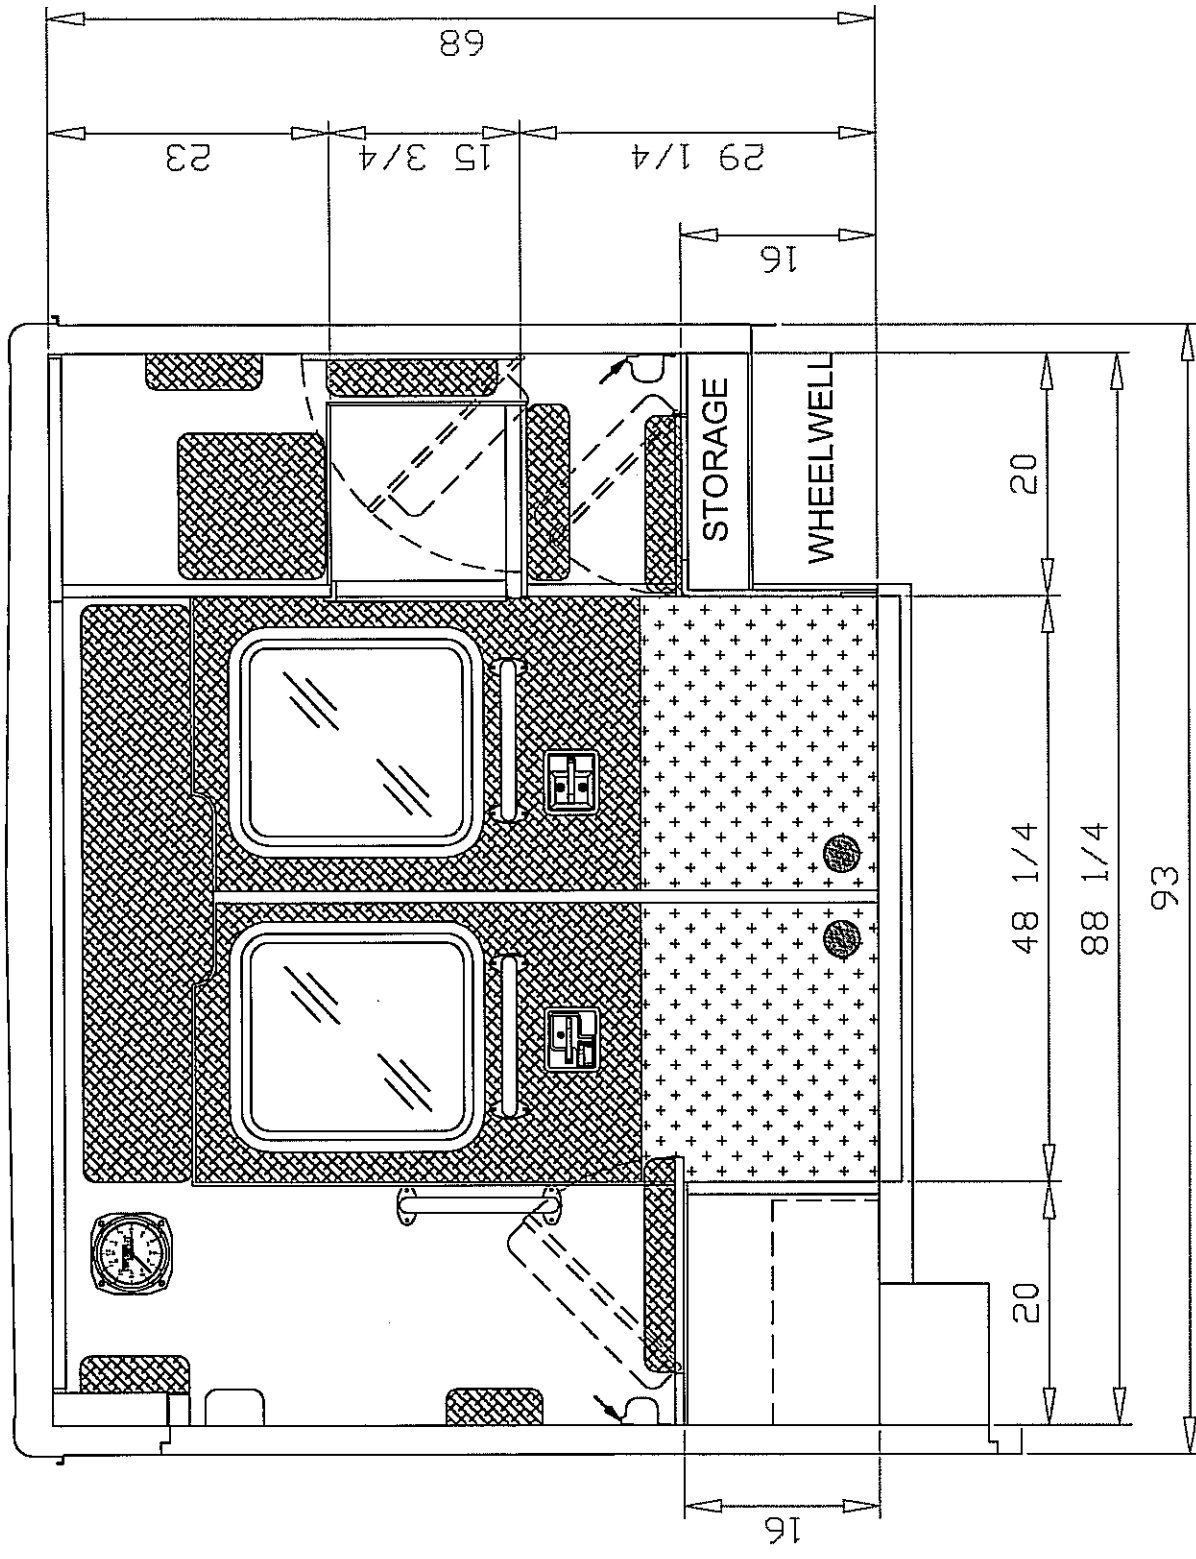


DRAWING TITLE: REAR INTERIOR VIEW - 68' H.I.R.
 MODEL/TYPE/CHASSIS/TYPE III - 148 COMMANDO
 DEALER / CUSTOMER: LIFE ALERT - MAHONING VALLEY EMS
 UNIT NUMBER: 4597 - 98 | PRINT NUMBER: T3-148CMDO-006

MARQUE ~ ~ ~ AMBULANCES

REVISIONS
DRAWN BY: <i>MZM</i>
DATE: 10/12/10
<small>Drawing is representative only - Dimensions shown are approximate and may vary from the completed vehicle. DO NOT scale this drawing!</small>

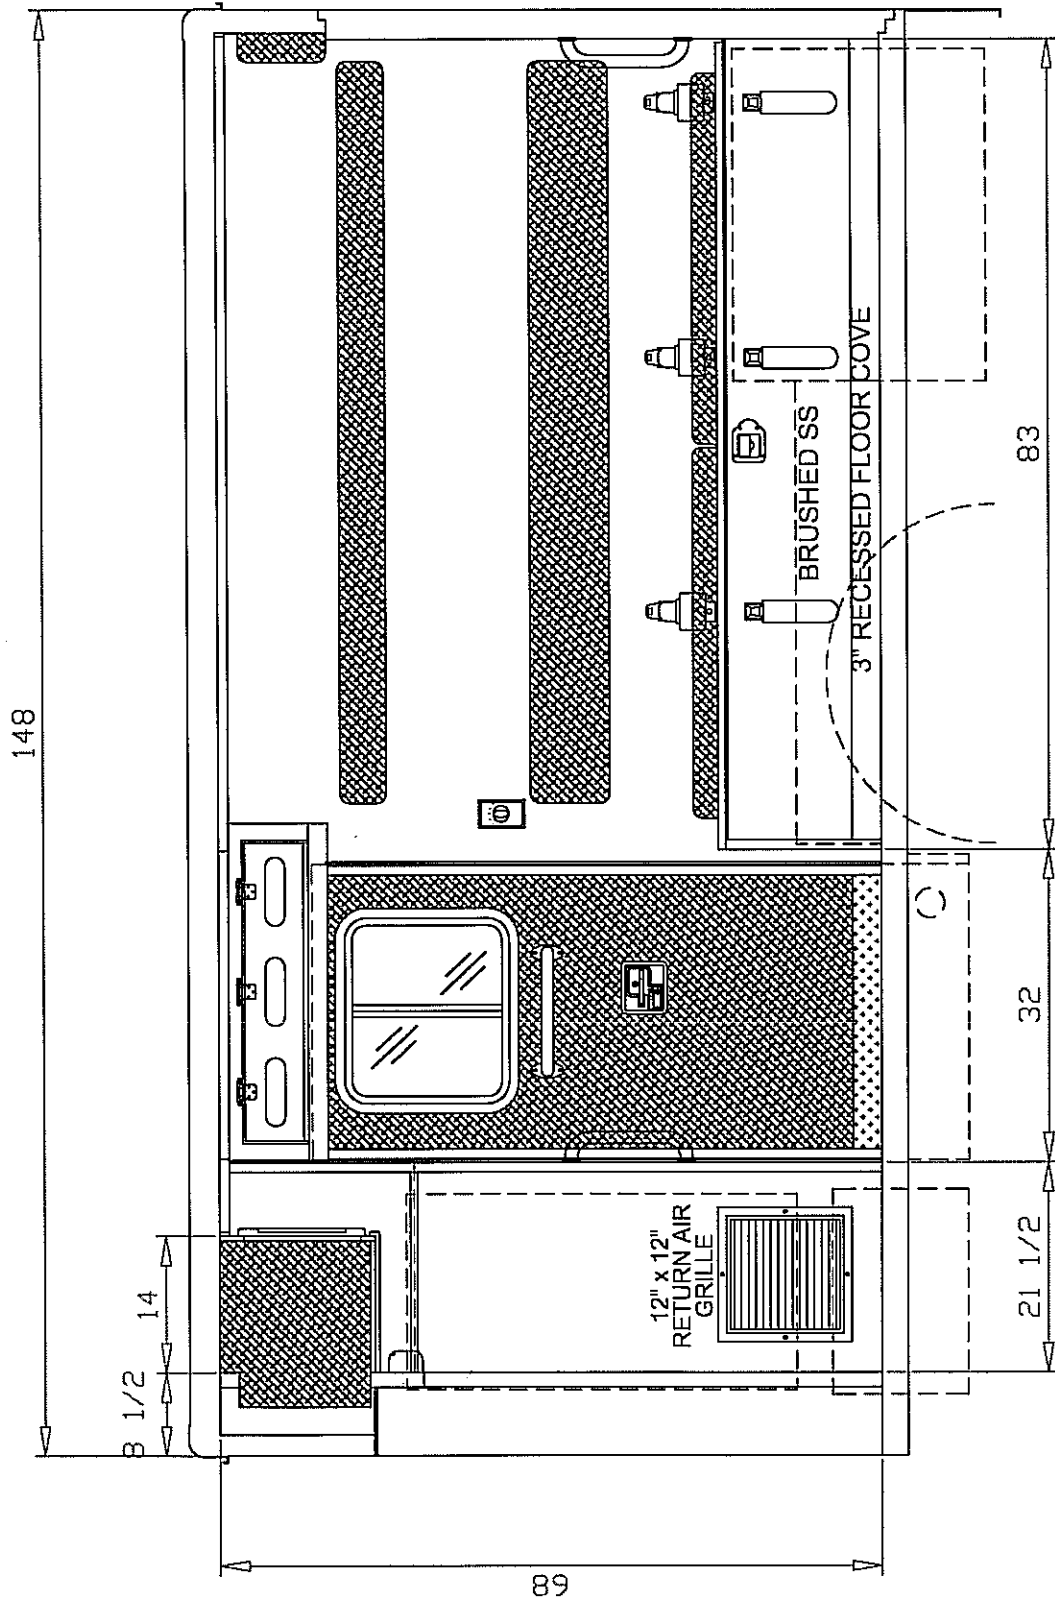

DRAWING TITLE: CURBSIDE INTERIOR VIEW - 68" H.R.
 MODEL/TYPE/CHASSIS TYPE III - 148 COMMANDO
 DEALER / CUSTOMER: LIFE ALERT - MAHONING VALLEY EMS
 UNIT NUMBER: 4597 - 98 | PRINT NUMBER: T3-148CMD0-007

MARQUE  AMBULANCES

DRAWN BY:	REVISIONS
<i>MRS</i>	
DATE: 10/12/10	
<small>Drawing is representative only - Dimensions shown are not necessarily from the completed vehicle. DO NOT scale this drawing!</small>	

148

136 1/2

57

28

51 1/2


14

68

36

12


9

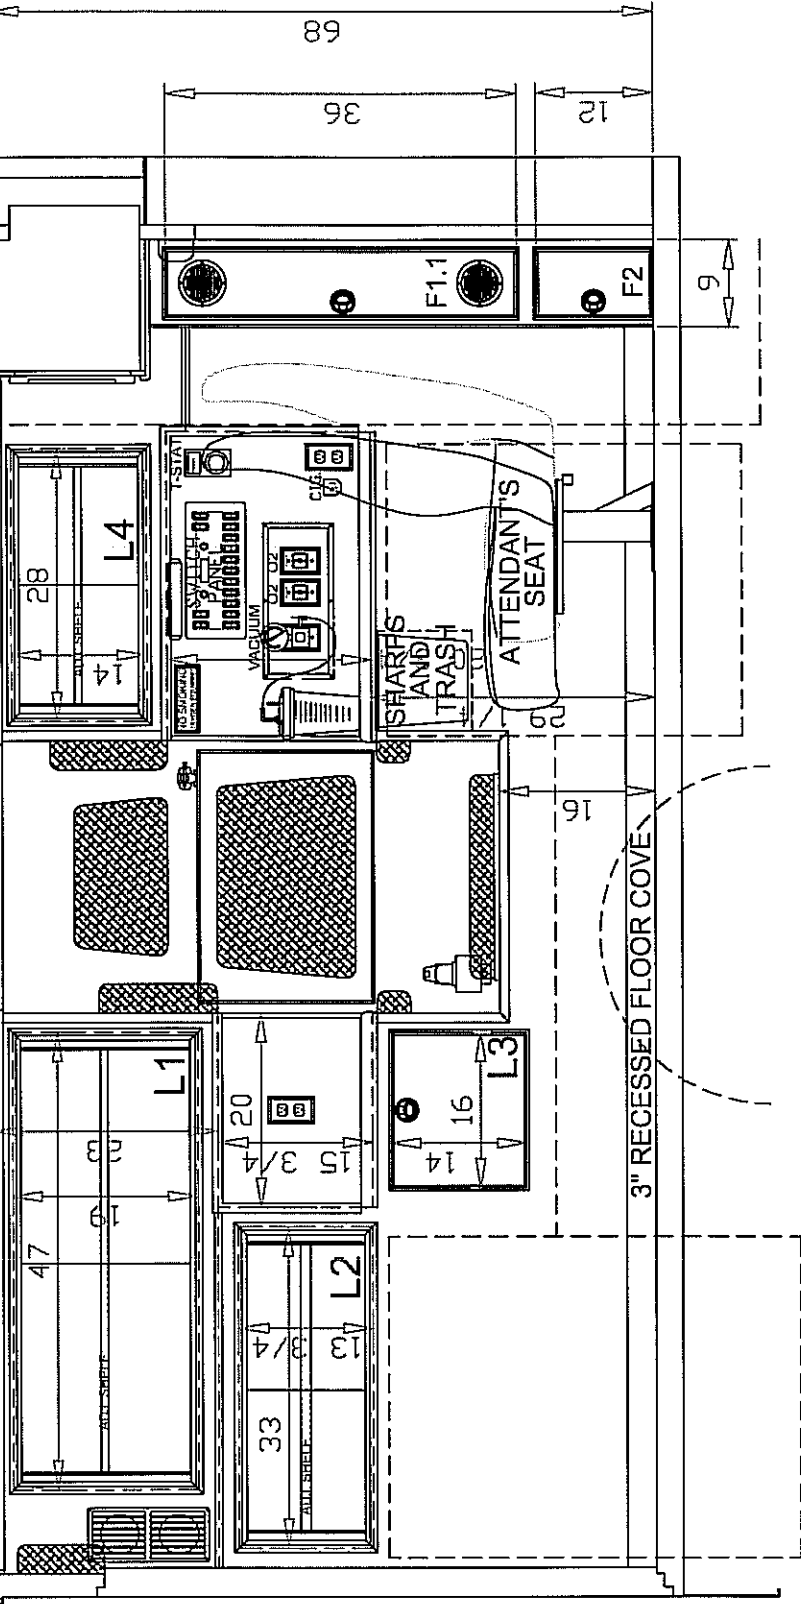


3" RECESSED FLOOR COVER

DRAWN BY: <i>MRY</i>	REVISIONS	DRAWING TITLE: STREETSIDE INTERIOR VIEW - 68' H.R.
DATE: 10/12/10		MODEL/TYPE/CHASSIS/TYPE III - 148 COMMANDO
Drawing is representative only - Dimensions shown are for information only (omit the complicated vehicle DO NOT scale this drawing)		DEALER / CUSTOMER: LIFE ALERT - MAHONING VALLEY EMS
		UNIT NUMBER: 4597-98 PRINT NUMBER: T3-148CMD0-008

MARQUE ~ ~ ~ AMBULANCES

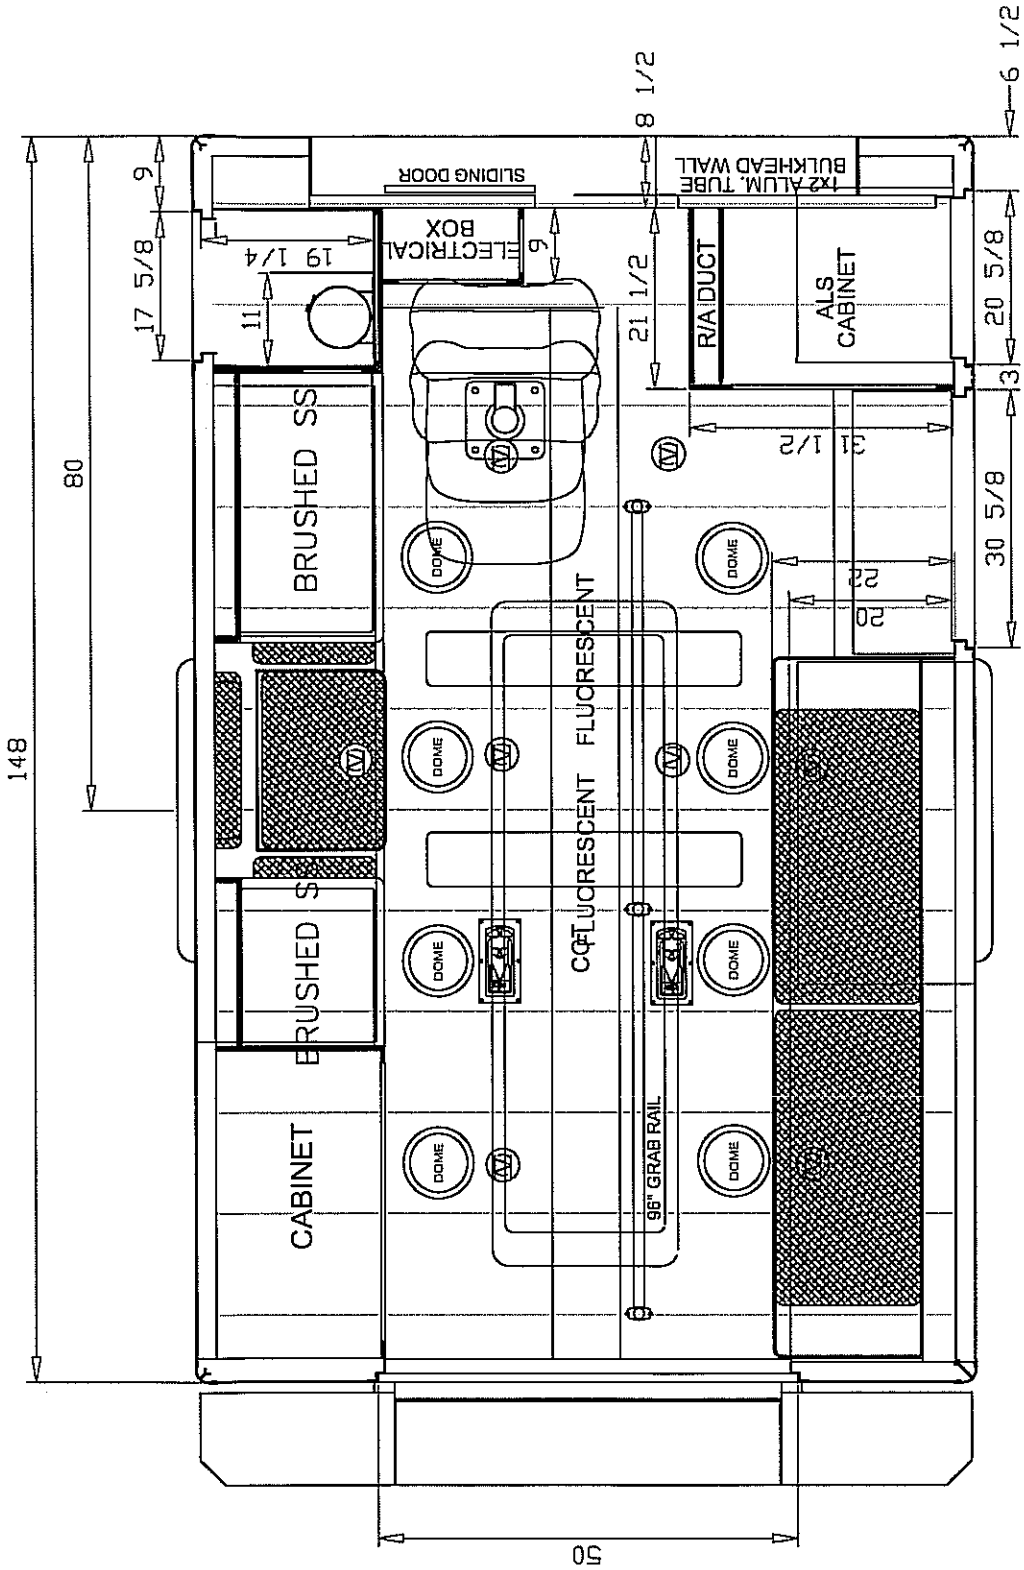

DRAWING TITLE: FLOOR PLAN
 TYPE/MODEL/CHASSIS TYPE III - 148 COMMANDO
 DEALER / CUSTOMER: LIFE ALERT - MAHONING VALLEY EMS
 UNIT NUMBER: 4597 - 98 | PRINT NUMBER: 3-148CMDCO-009

MARQUE ~ ~ ~  AMBULANCES

DRAWN BY:	REVISIONS
MCR	
DATE:	
10/12/10	

Drawing is representative only - Dimensions shown are approximate and may vary from the completed vehicle DO NOT SCALE THE DRAWING